


REVISIONS				
ZONE	LTR	DESCRIPTION	DATE	APPROVED



MATCH LINE "G-1" SEE THIS SHEET

MATCH LINE "F-3" SEE SHEET 11




MATCH LINE "G-2" SEE THIS SHEET

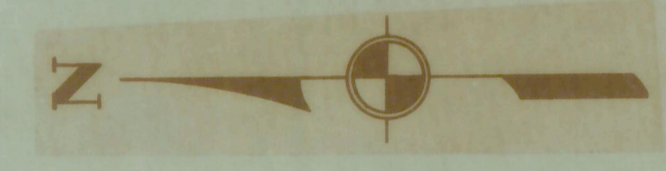

MATCH LINE "G-1" SEE THIS SHEET

MATCH LINE "G-2" SEE THIS SHEET

MATCH LINE "G-3" SEE SHEET 13

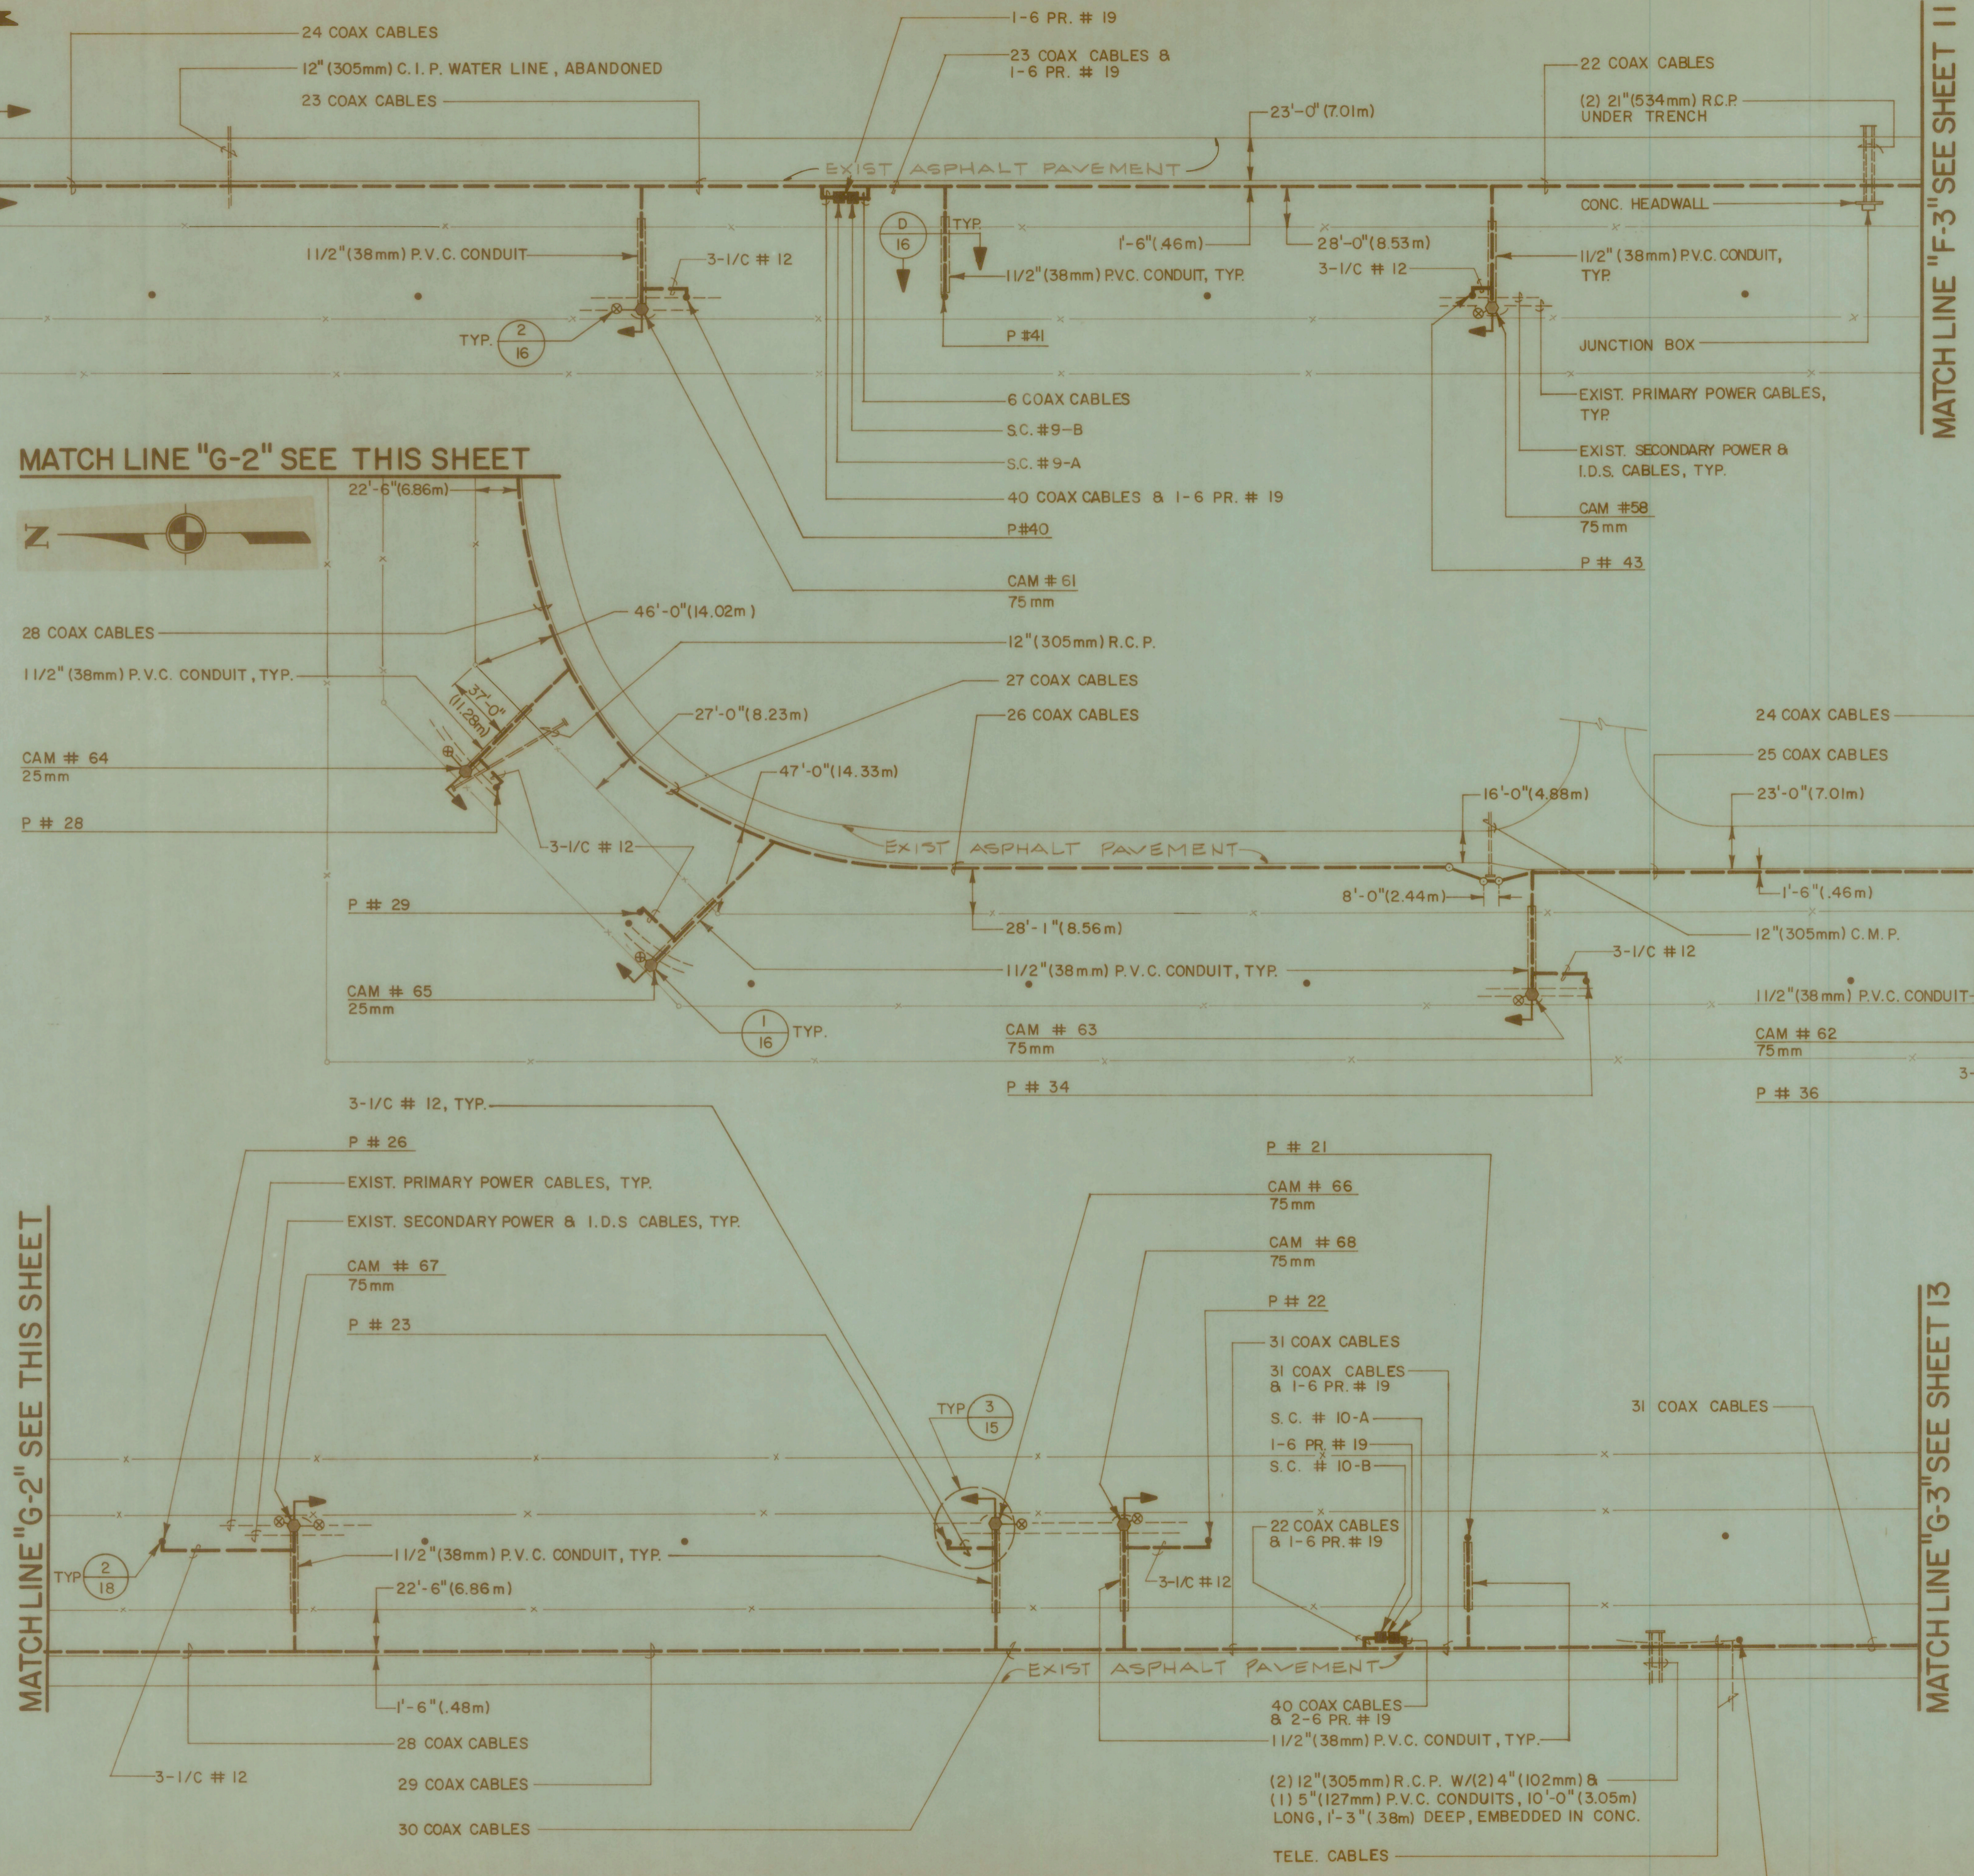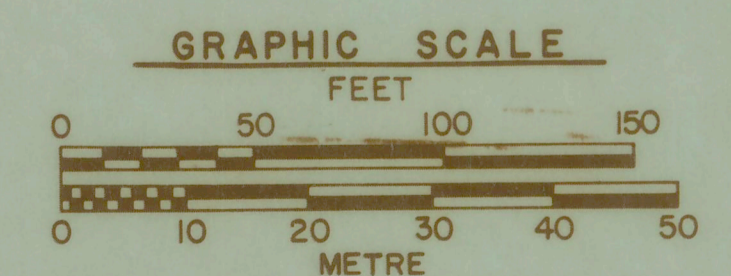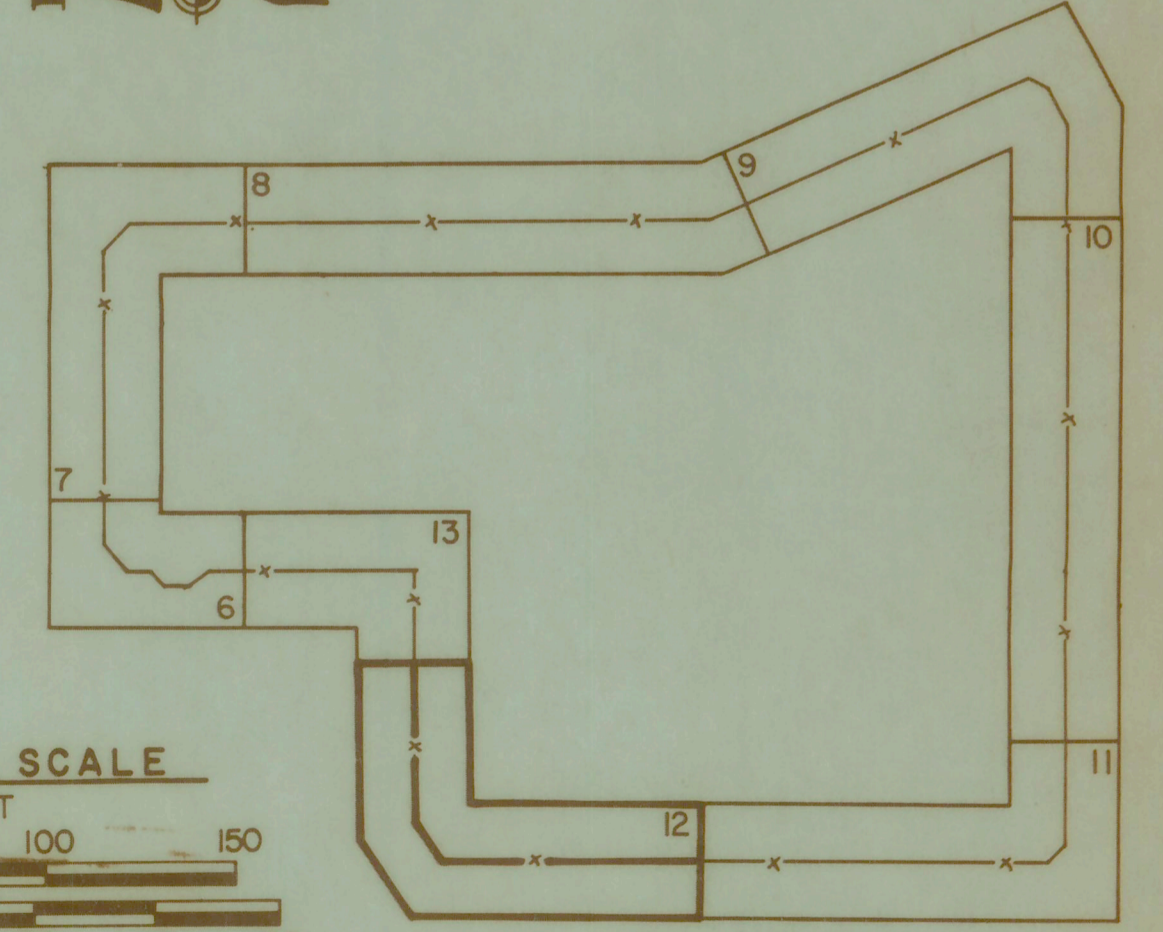

DRAFTSMAN V. CORDOVA 4-27-82	U.S. ARMY HOLMES & NARVER, INC. SENECA ARMY DEPOT	
CHECKER R. RUTLEDGE R. GUTIERREZ 5-7-82	TITLE AN/GXS-2 SYSTEM TRENCHING & FOUNDATION PLAN	
ENGINEER D. VATH 5-11-82	DESIGN ACTIVITY AUTHENTICATION	CODE IDENT NO. DRAWING NUMBER
PROJ. ENGR.	SCALE 1:600	SHEET 12 OF 18