

REVISIONS				
ZONE	LTR.	DESCRIPTION	DATE	APPROVED



MATCH LINE "G-1" SEE THIS SHEET

MATCH LINE "F-3" SEE SHEET 11




**MATCH LINE "G-2" SEE THIS SHEET**



MATCH LINE "G-1" SEE THIS SHEET

MATCH LINE "G-2" SEE THIS SHEET

MATCH LINE "G-3" SEE SHEET 13

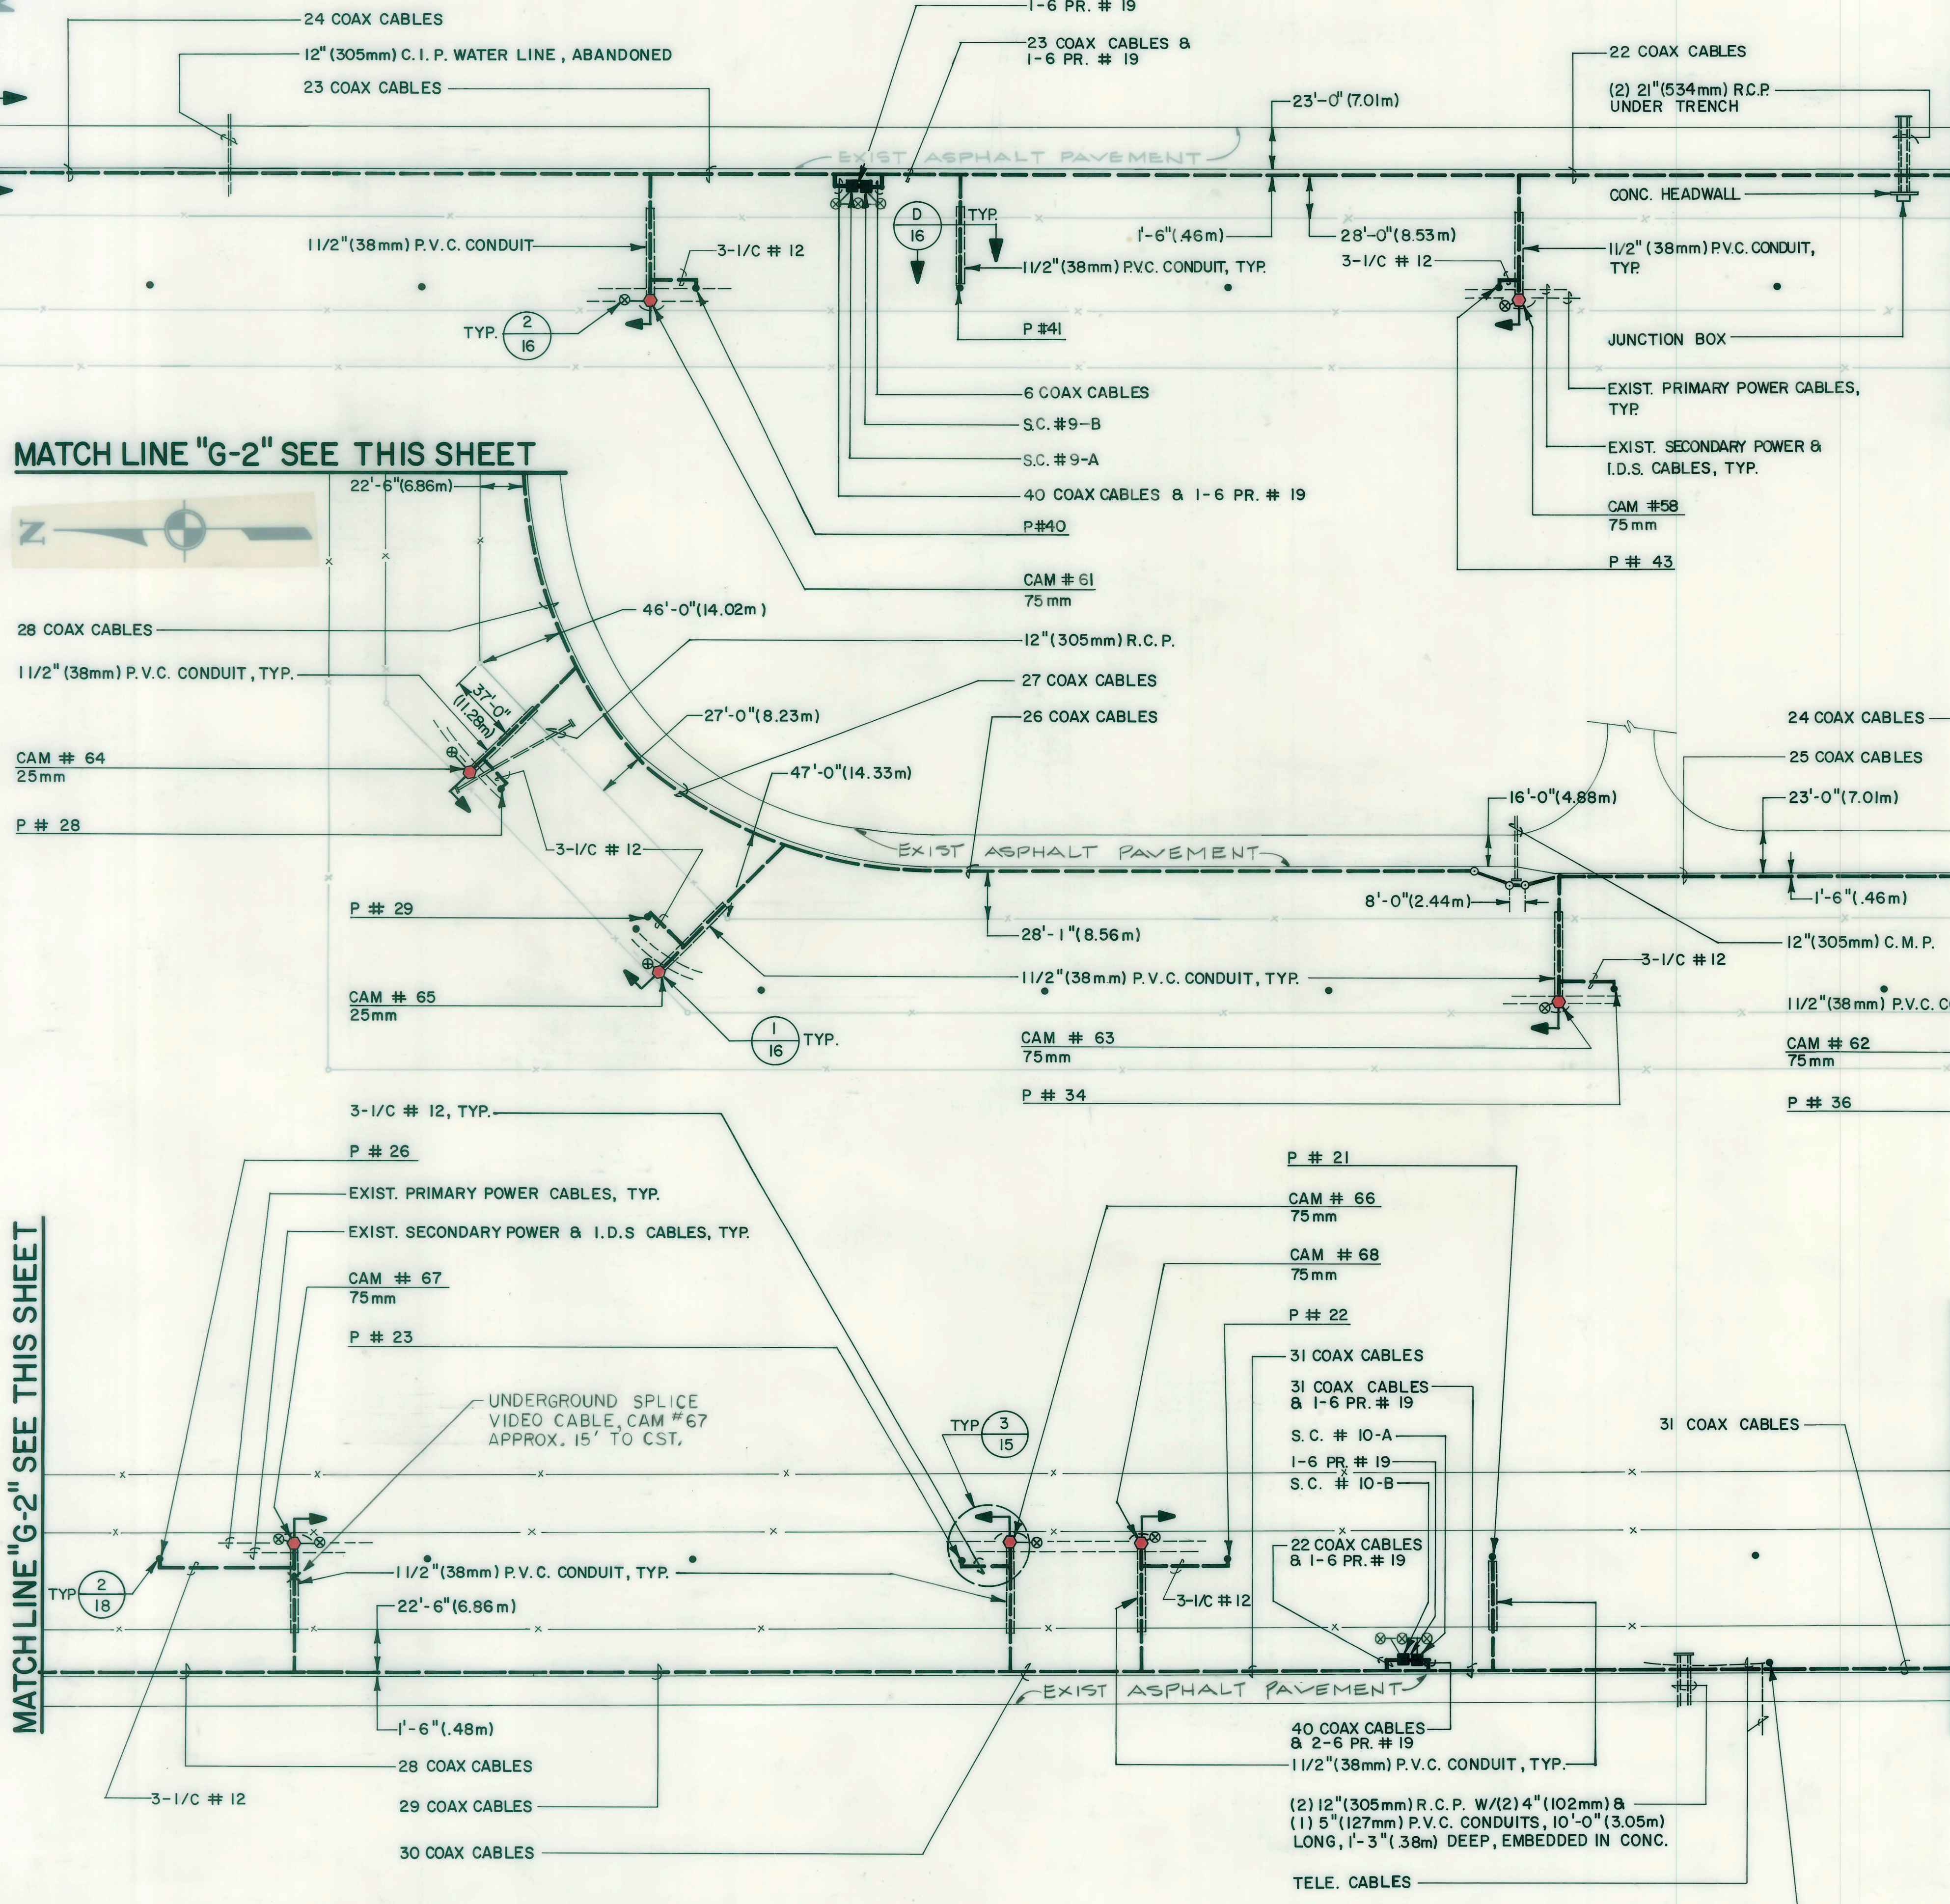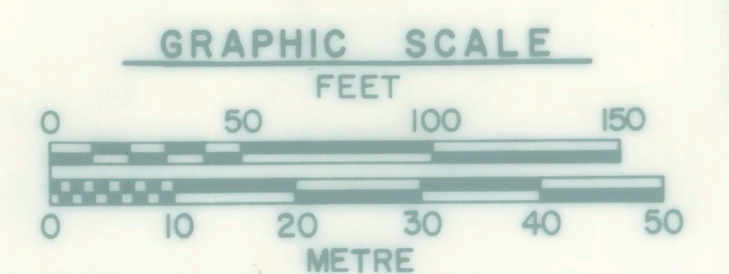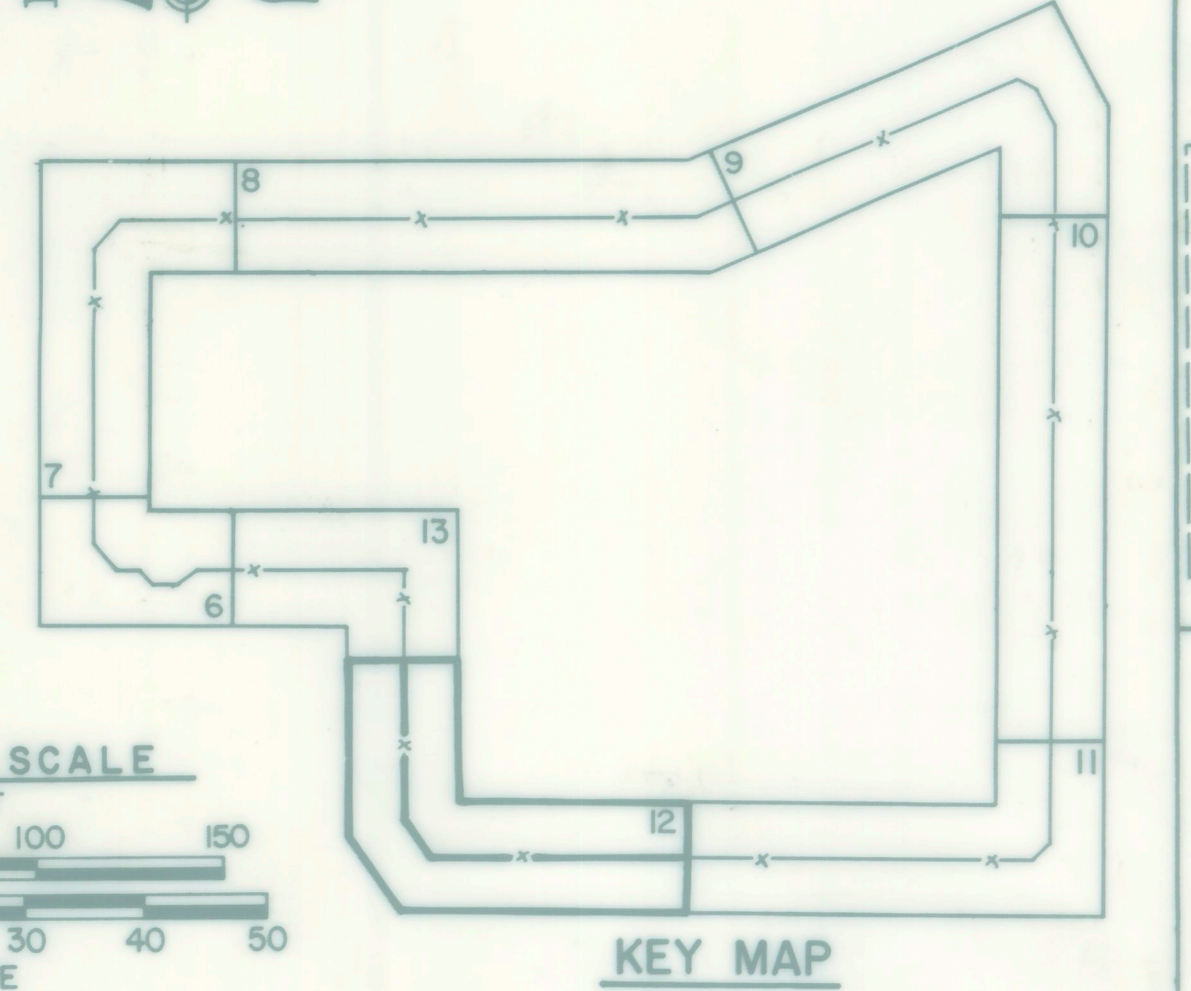

DRAFTSMAN	V. CORDOVA	4-27-82	HERMES & NAVIER, INC. U.S. ARMY SENECA ARMY DEPOT
CHECKER	R. RUTLEDGE R. GUTIERREZ	5-7-82	
ENGINEER	D. VATH	5-11-82	TITLE
PROJ. ENGR.			<b>AN/GXS-3 SYSTEM</b>
CONTRACT NUMBER			<b>TRENCHING &amp; FOUNDATION PLAN</b>
DESIGN ACTIVITY AUTHENTICATION			SIZE
			<b>D</b>
			SCALE
			<b>1:600</b>
			DRAWING NUMBER
			SHEET
			<b>12 OF 18</b>