


PREPARED FOR:

**AIR FORCE CENTER FOR  
ENGINEERING AND THE ENVIRONMENT  
REMEDIATION OF MUNITIONS WASHOUT FACILITY  
(SEAD-4) AND THE FORMER BUILDING 2079  
BOILER BLOWDOWN PIT (SEAD-38)  
SENECA ARMY DEPOT ACTIVITY  
ROMULUS, NEW YORK  
CONSTRUCTION COMPLETION REPORT  
(JANUARY 2009)**

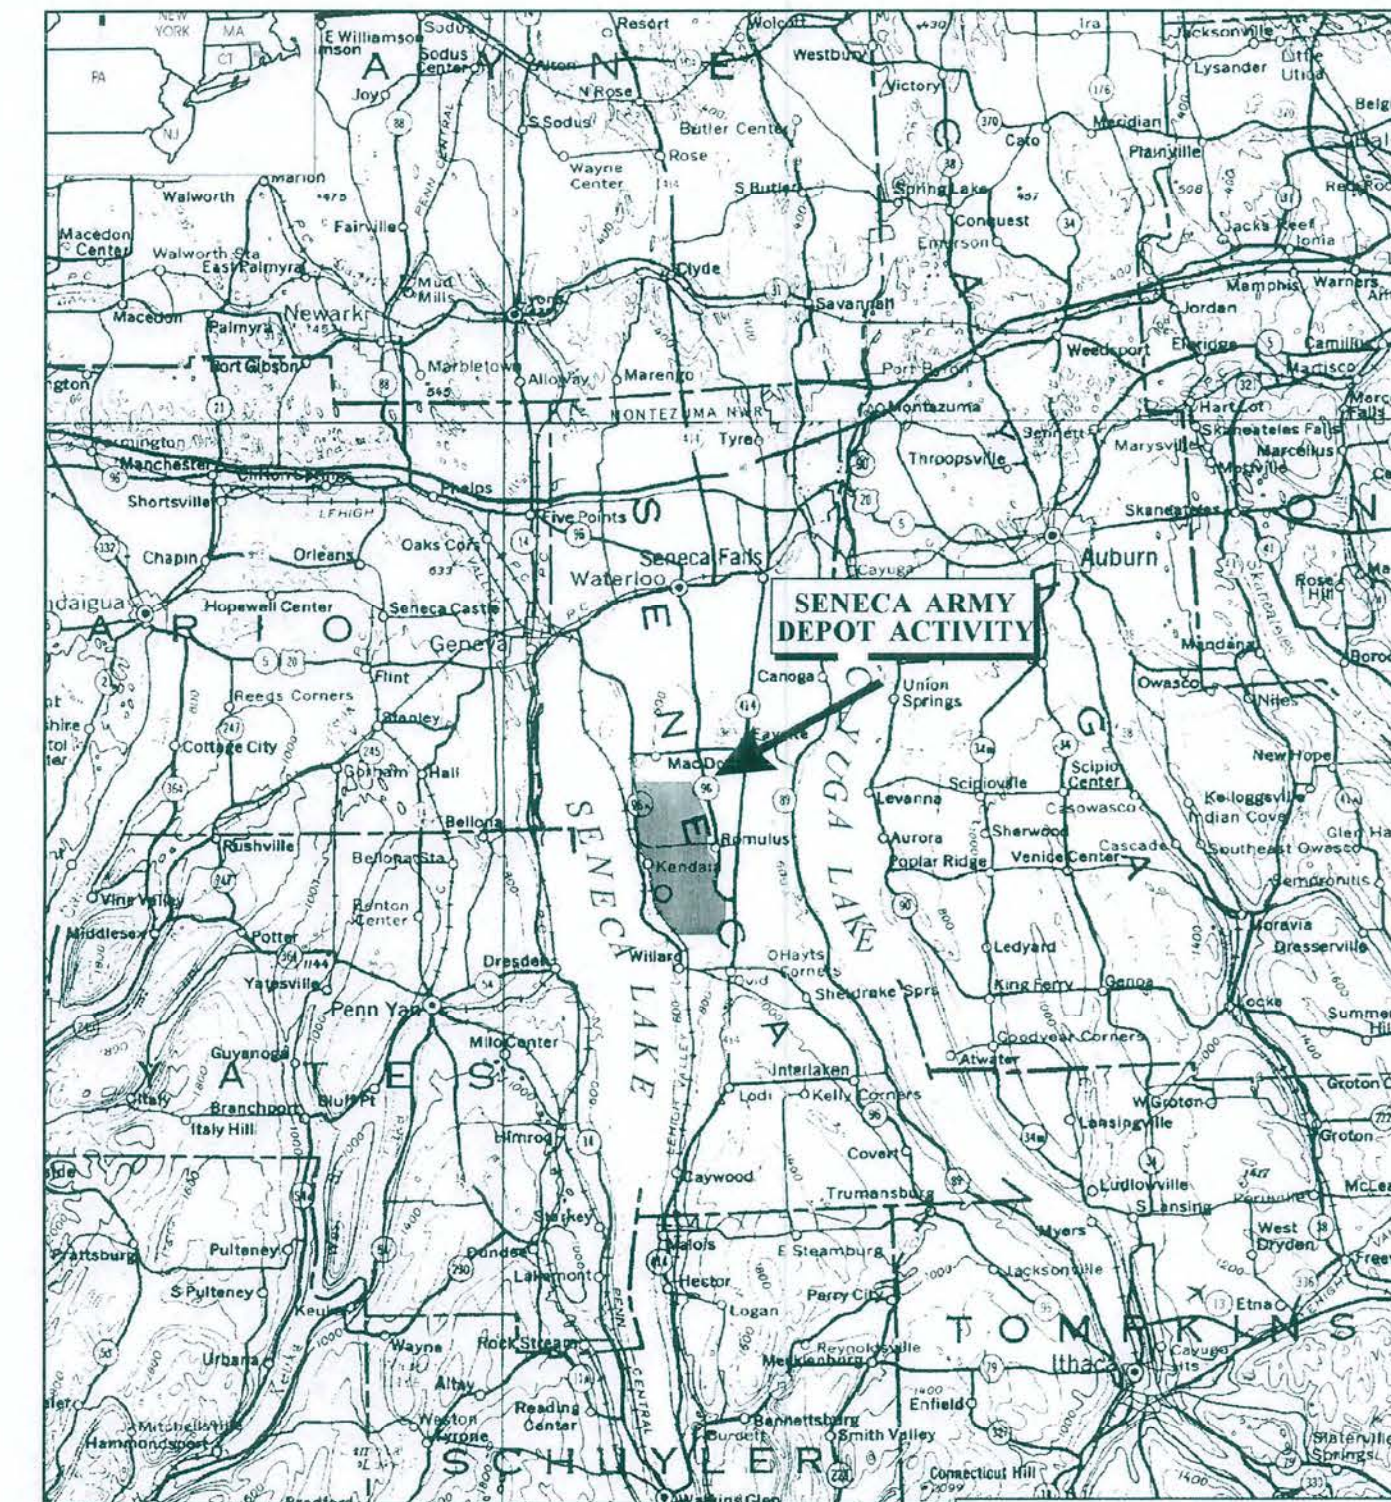

LOCATION MAP

DRAWING LIST

<u>SHEET NO.</u>	<u>REVISION</u>	<u>DESCRIPTION</u>
C-1	-	TITLE SHEET
C-2	-	SEAD-4 & SEAD-38 EXISTING CONDITIONS PLAN
C-3	-	SEAD-4 & SEAD-38 EXCAVATION AREAS
C-4	-	AREA 1 EXCAVATION AREA & FINAL CONFIRMATORY SAMPLE LOCATIONS
C-5	-	AREA 2 & DITCHES 1, 2, & 3 EXCAVATION AREAS & FINAL CONFIRMATORY SAMPLE LOCATIONS
C-6	-	AREA 3 AND DITCH 4 EXCAVATION AREAS & FINAL CONFIRMATORY SAMPLE LOCATIONS
C-7	-	SEAD-38 EXCAVATION AREA & FINAL CONFIRMATORY SAMPLE LOCATIONS



SITE PLAN  
NTS



**PARSONS**

CLIENT/PROJECT TITLE  
**SENECA ARMY DEPOT  
CONSTRUCTION COMPLETION REPORT  
SEAD-4 AND SEAD-38**

DEPT. ENVIRONMENTAL ENGINEERING Dwg. No. 745172-04200

C-1  
TITLE SHEET

SCALE NA DATE JANUARY 2009 REV -