


PREPARED FOR:

**AIR FORCE CENTER FOR ENGINEERING
AND THE ENVIRONMENT
REMEDIATION OF ABANDONED DEACTIVATION
FURNACE (SEAD-16) AND THE
ACTIVE DEACTIVATION FURNACE (SEAD-17)
SENECA ARMY DEPOT
ROMULUS, NEW YORK**

**CONSTRUCTION COMPLETION REPORT
(DECEMBER 2007)**

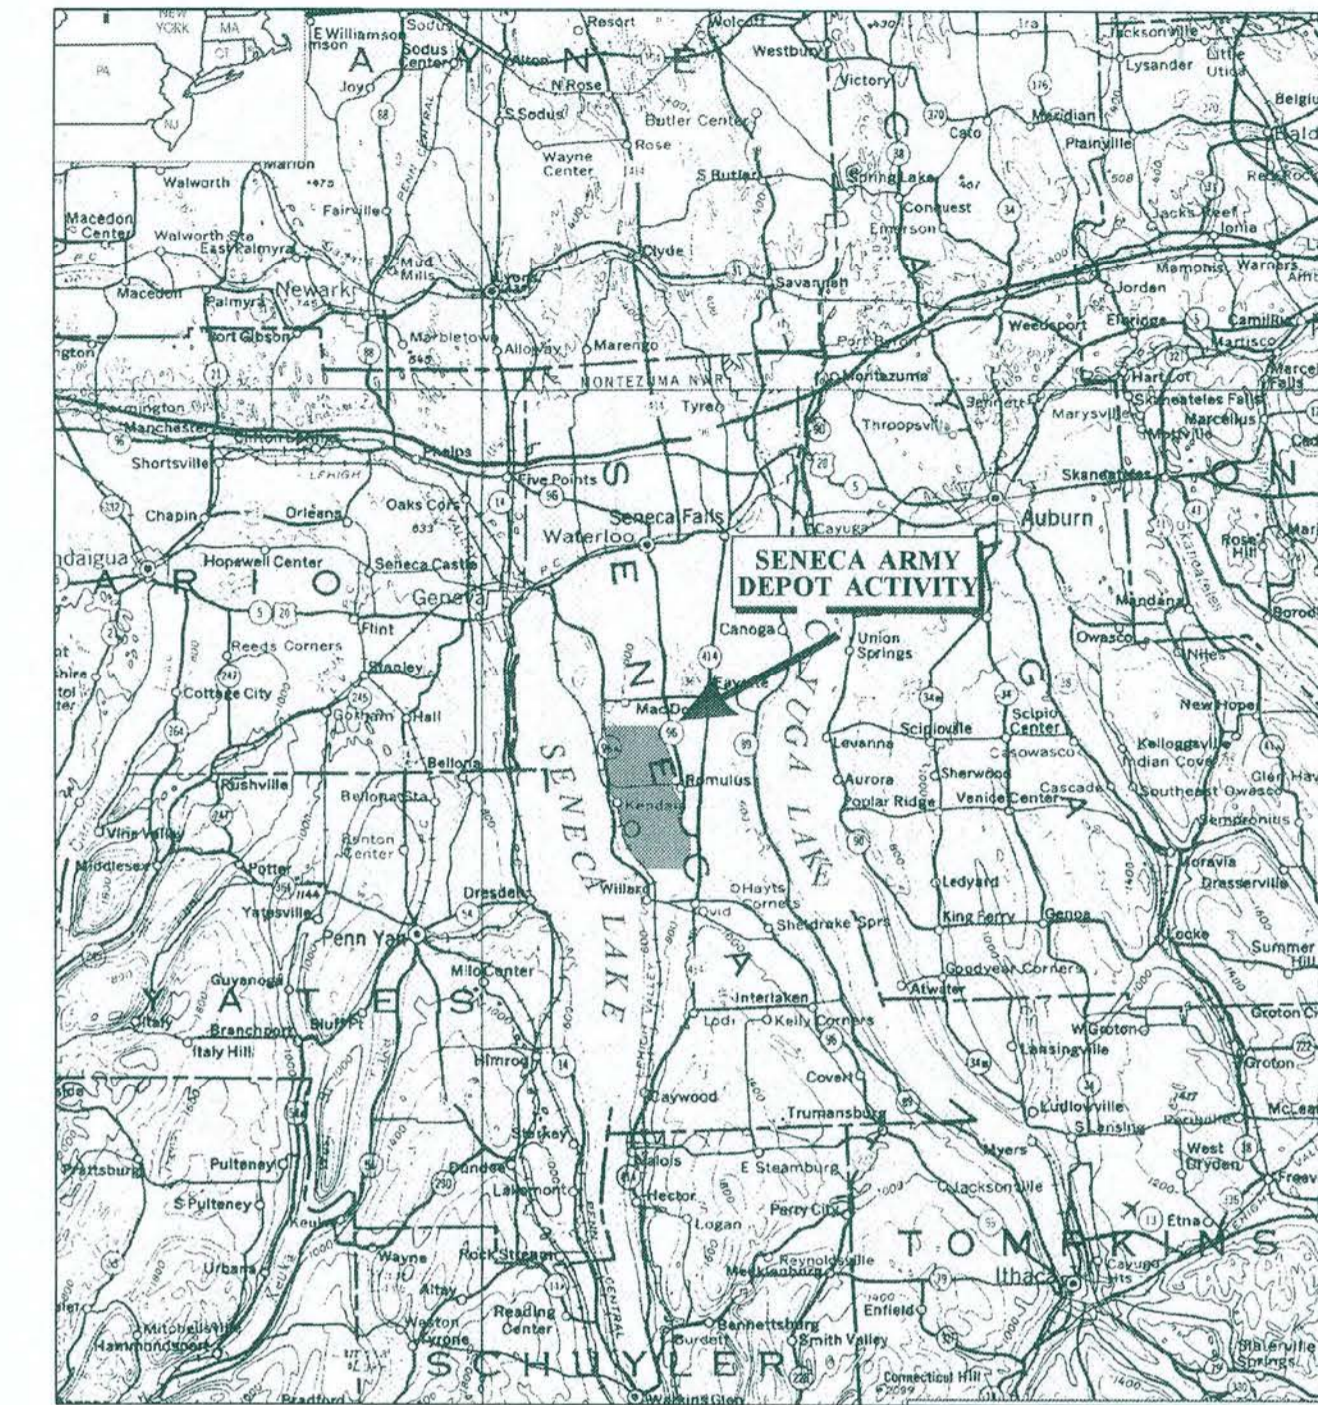

LOCATION MAP

DRAWING LIST

SHEET NO.	REVISION NO.	DESCRIPTION
C-1	-	TITLE SHEET
C-2	-	SEAD-16 SITE PLAN
C-3	-	SEAD-17 SITE PLAN
C-4	-	SEAD-16 EXCAVATION AREA & FINAL CONFIRMATORY SAMPLE LOCATIONS
C-5	-	SEAD-17 EXCAVATION AREA & FINAL CONFIRMATORY SAMPLE LOCATIONS



SITE PLAN
NTS

P:\PIT\Projects\Seneca PBC\SEAD-16_17\Construction Completion Rpt\Draft\Figures\C-1.dwg

01331-03



PARSONS



CLIENT/PROJECT TITLE
**SENECA ARMY DEPOT
CONSTRUCTION COMPLETION REPORT
SEAD-16 AND SEAD-17**

DEPT. ENVIRONMENTAL ENGINEERING Dwg. No. 745172-01200

C-1
TITLE SHEET

SCALE NA DATE DECEMBER 2007 REV -