


PREPARED FOR:

AIR FORCE CENTER OF ENVIRONMENTAL EXCELLENCE

REMEDIAL DESIGN FOR THE ASH LANDFILL OPERABLE UNIT SENECA ARMY DEPOT ROMULUS, NEW YORK

DRAFT DESIGN DRAWINGS (JUNE 2006)

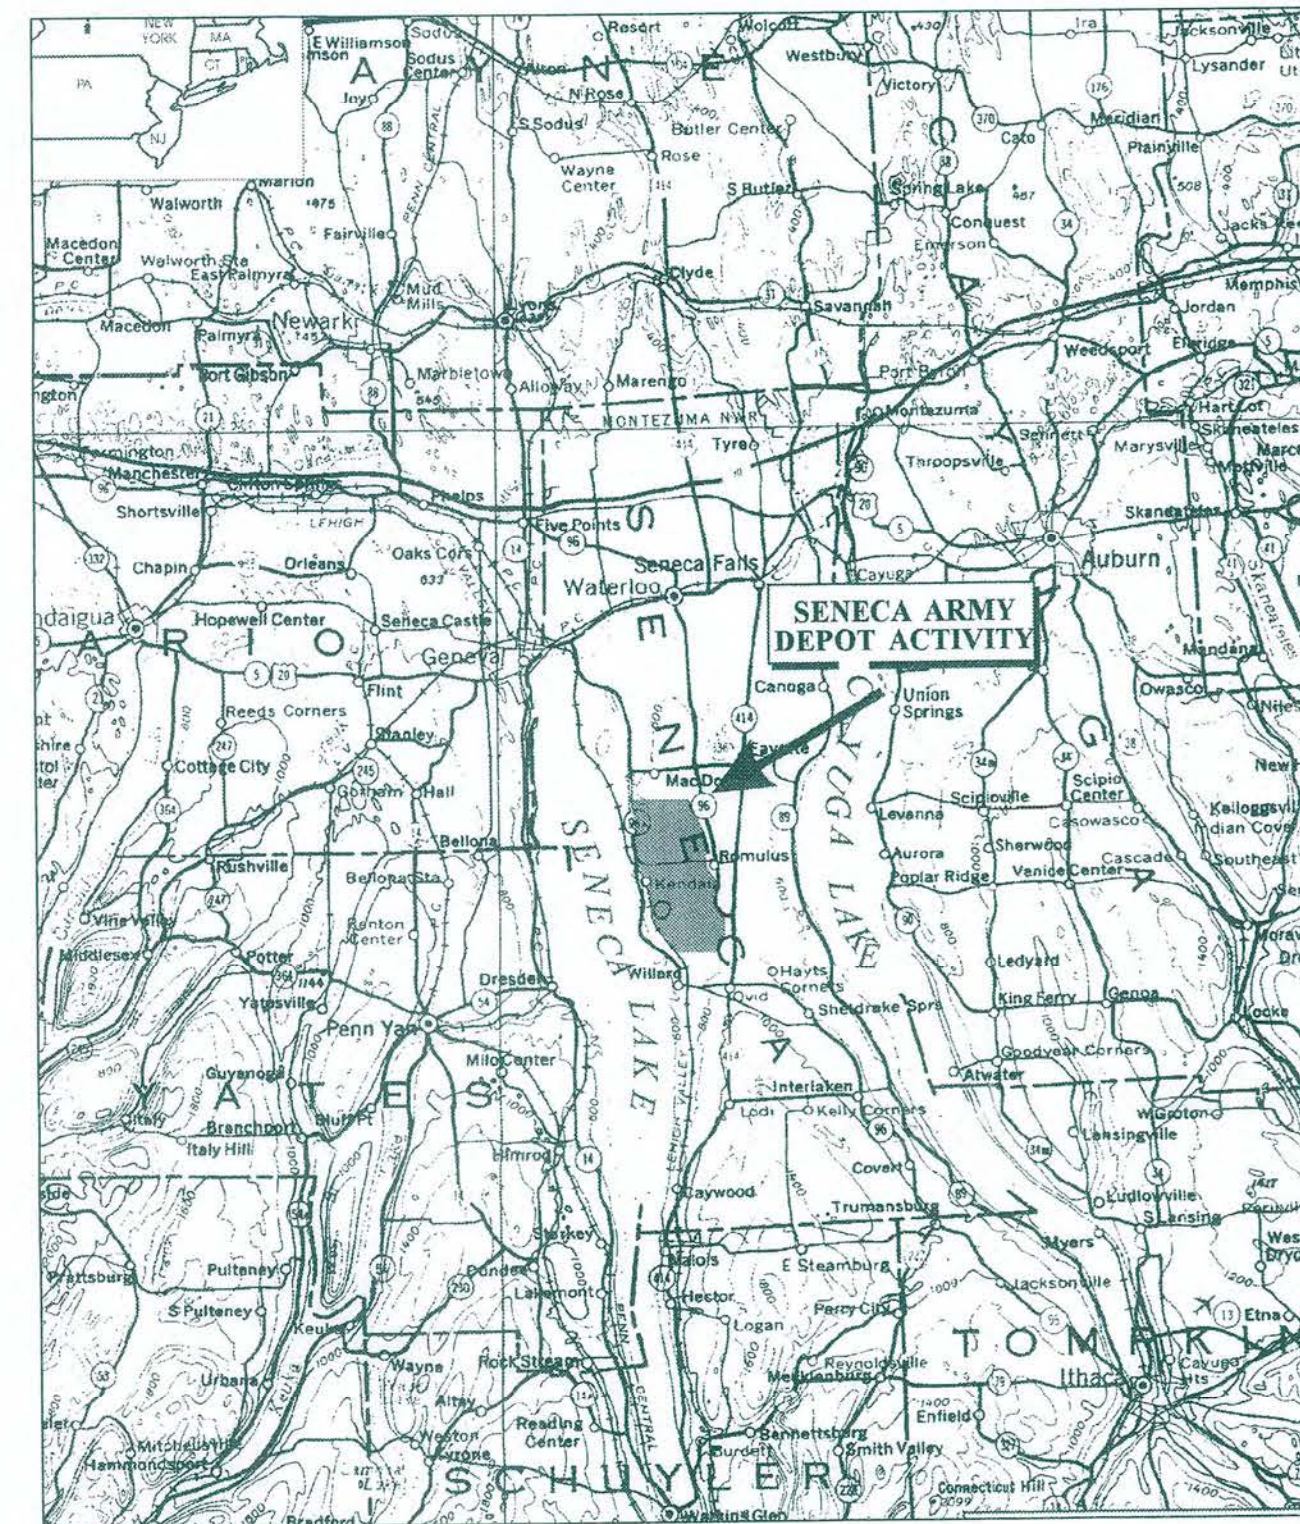

LOCATION MAP

DRAWING LIST

<u>SHEET NO.</u>	<u>REVISION NO.</u>	<u>DESCRIPTION</u>
C-1		TITLE SHEET
C-2		EXISTING CONDITIONS PLAN
C-3		SOIL REMEDIATION: EXCAVATION AND GRADING PLAN
C-4		GROUNDWATER REMEDIATION: BIOWALLS LAYOUT
C-5		DETAILS



SITE PLAN
NTS



PARSONS



CLIENT/PROJECT TITLE

SENECA ARMY DEPOT
ASH LANDFILL
REMEDIAL DESIGN

DEPT. ENVIRONMENTAL ENGINEERING Dwg. No. 744538-01400

C-1
TITLE SHEET

SCALE NA DATE JUNE 2006 REV -

01543-M4