



1
PROFILE
INTAKE PIPE
 SCALE: HORZ. 1" = 40'
 VERT. 1" = 10'
 CROSS REFERENCE:

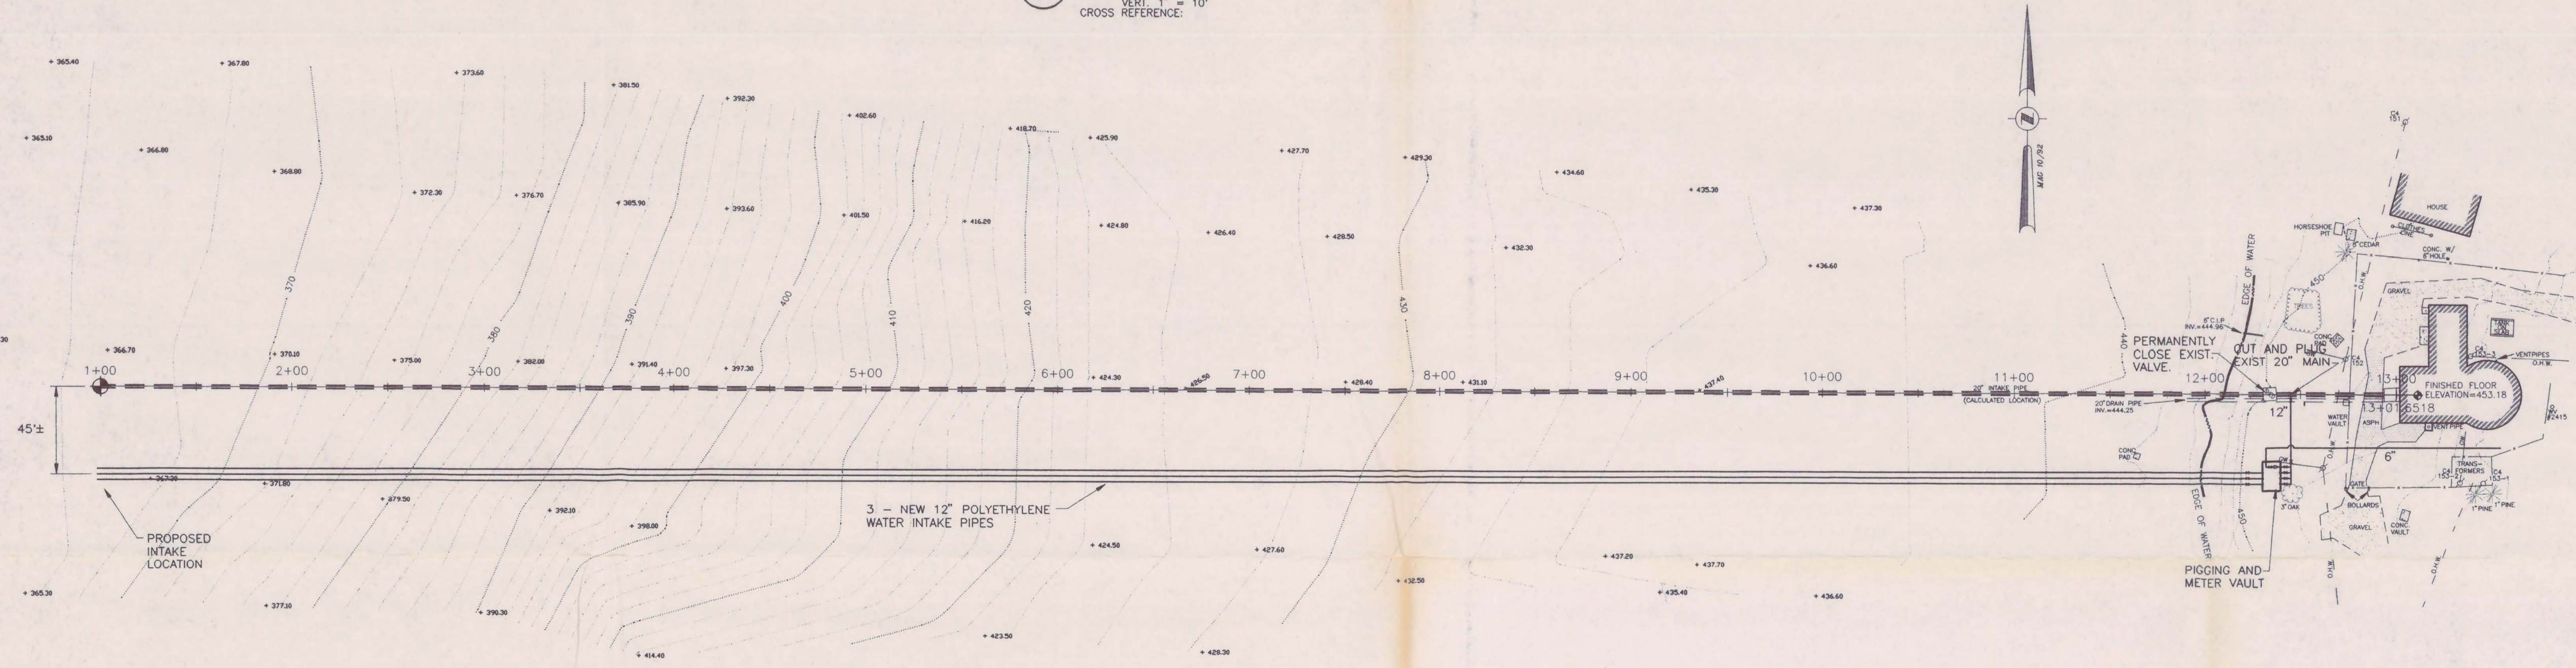

2
BATHYMETRIC PLAN
INTAKE PIPE
 SCALE: 1" = 40'
 CROSS REFERENCE:

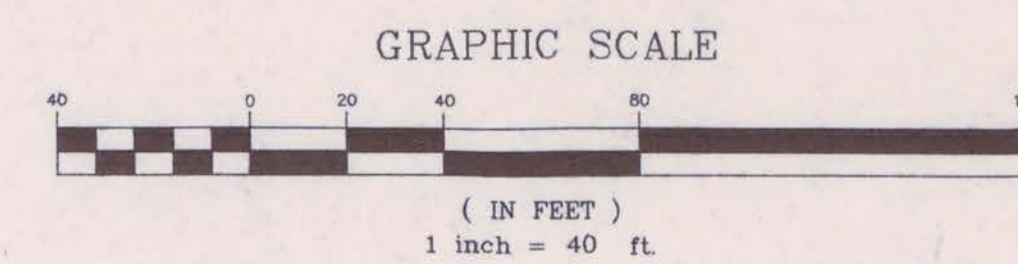

MAP REFERENCE
 1.) MAP ENTITLED "NAVAL TRAINING STATION, SAMPSON, N.Y. WATER PUMPING STATION, FLOOR PLAN & OUTSIDE PIPING", Y&D DWG. NO. 243,282, BLDG. 2411, DATED 7-27-1942, LAST REVISED 8-12-1942

C.T. MALE ASSOCIATES, P.C.
 APR 23 1993
 PRINTED AND ISSUED

Revision	Description	Date	Approved
C.T. MALE ASSOCIATES, P.C. ENGINEER - ARCHITECT 50 CENTURY HILL DRIVE LATHAM, NY 12110		U.S. ARMY ENGINEER DISTRICT CORPS OF ENGINEERS NEW YORK, NEW YORK	
Designed by:	G.R.M.	SENECA ARMY DEPOT	
Drawn by:	E.W.B.	WATER SUPPLY INTAKE	
Checked by:		FIGURE 3 PROPOSED INTAKE PLAN AND PROFILE NEW YORK	
Submitted by:			
Reviewed by:		Approval Recommended:	Sheet reference number:
Concurred:		Approved by:	Date: 2/17/93
			Scale: 1" = 40'
			Sheet 1 of