



Apr 22, 1993 - 1445

CTM FILE NO. 92-638


CTM PROJ. NO. 92-894

PLOT SCALE FACTOR: 1=10

CAD FILE NAME: 92-C2-894

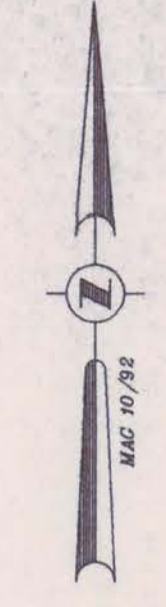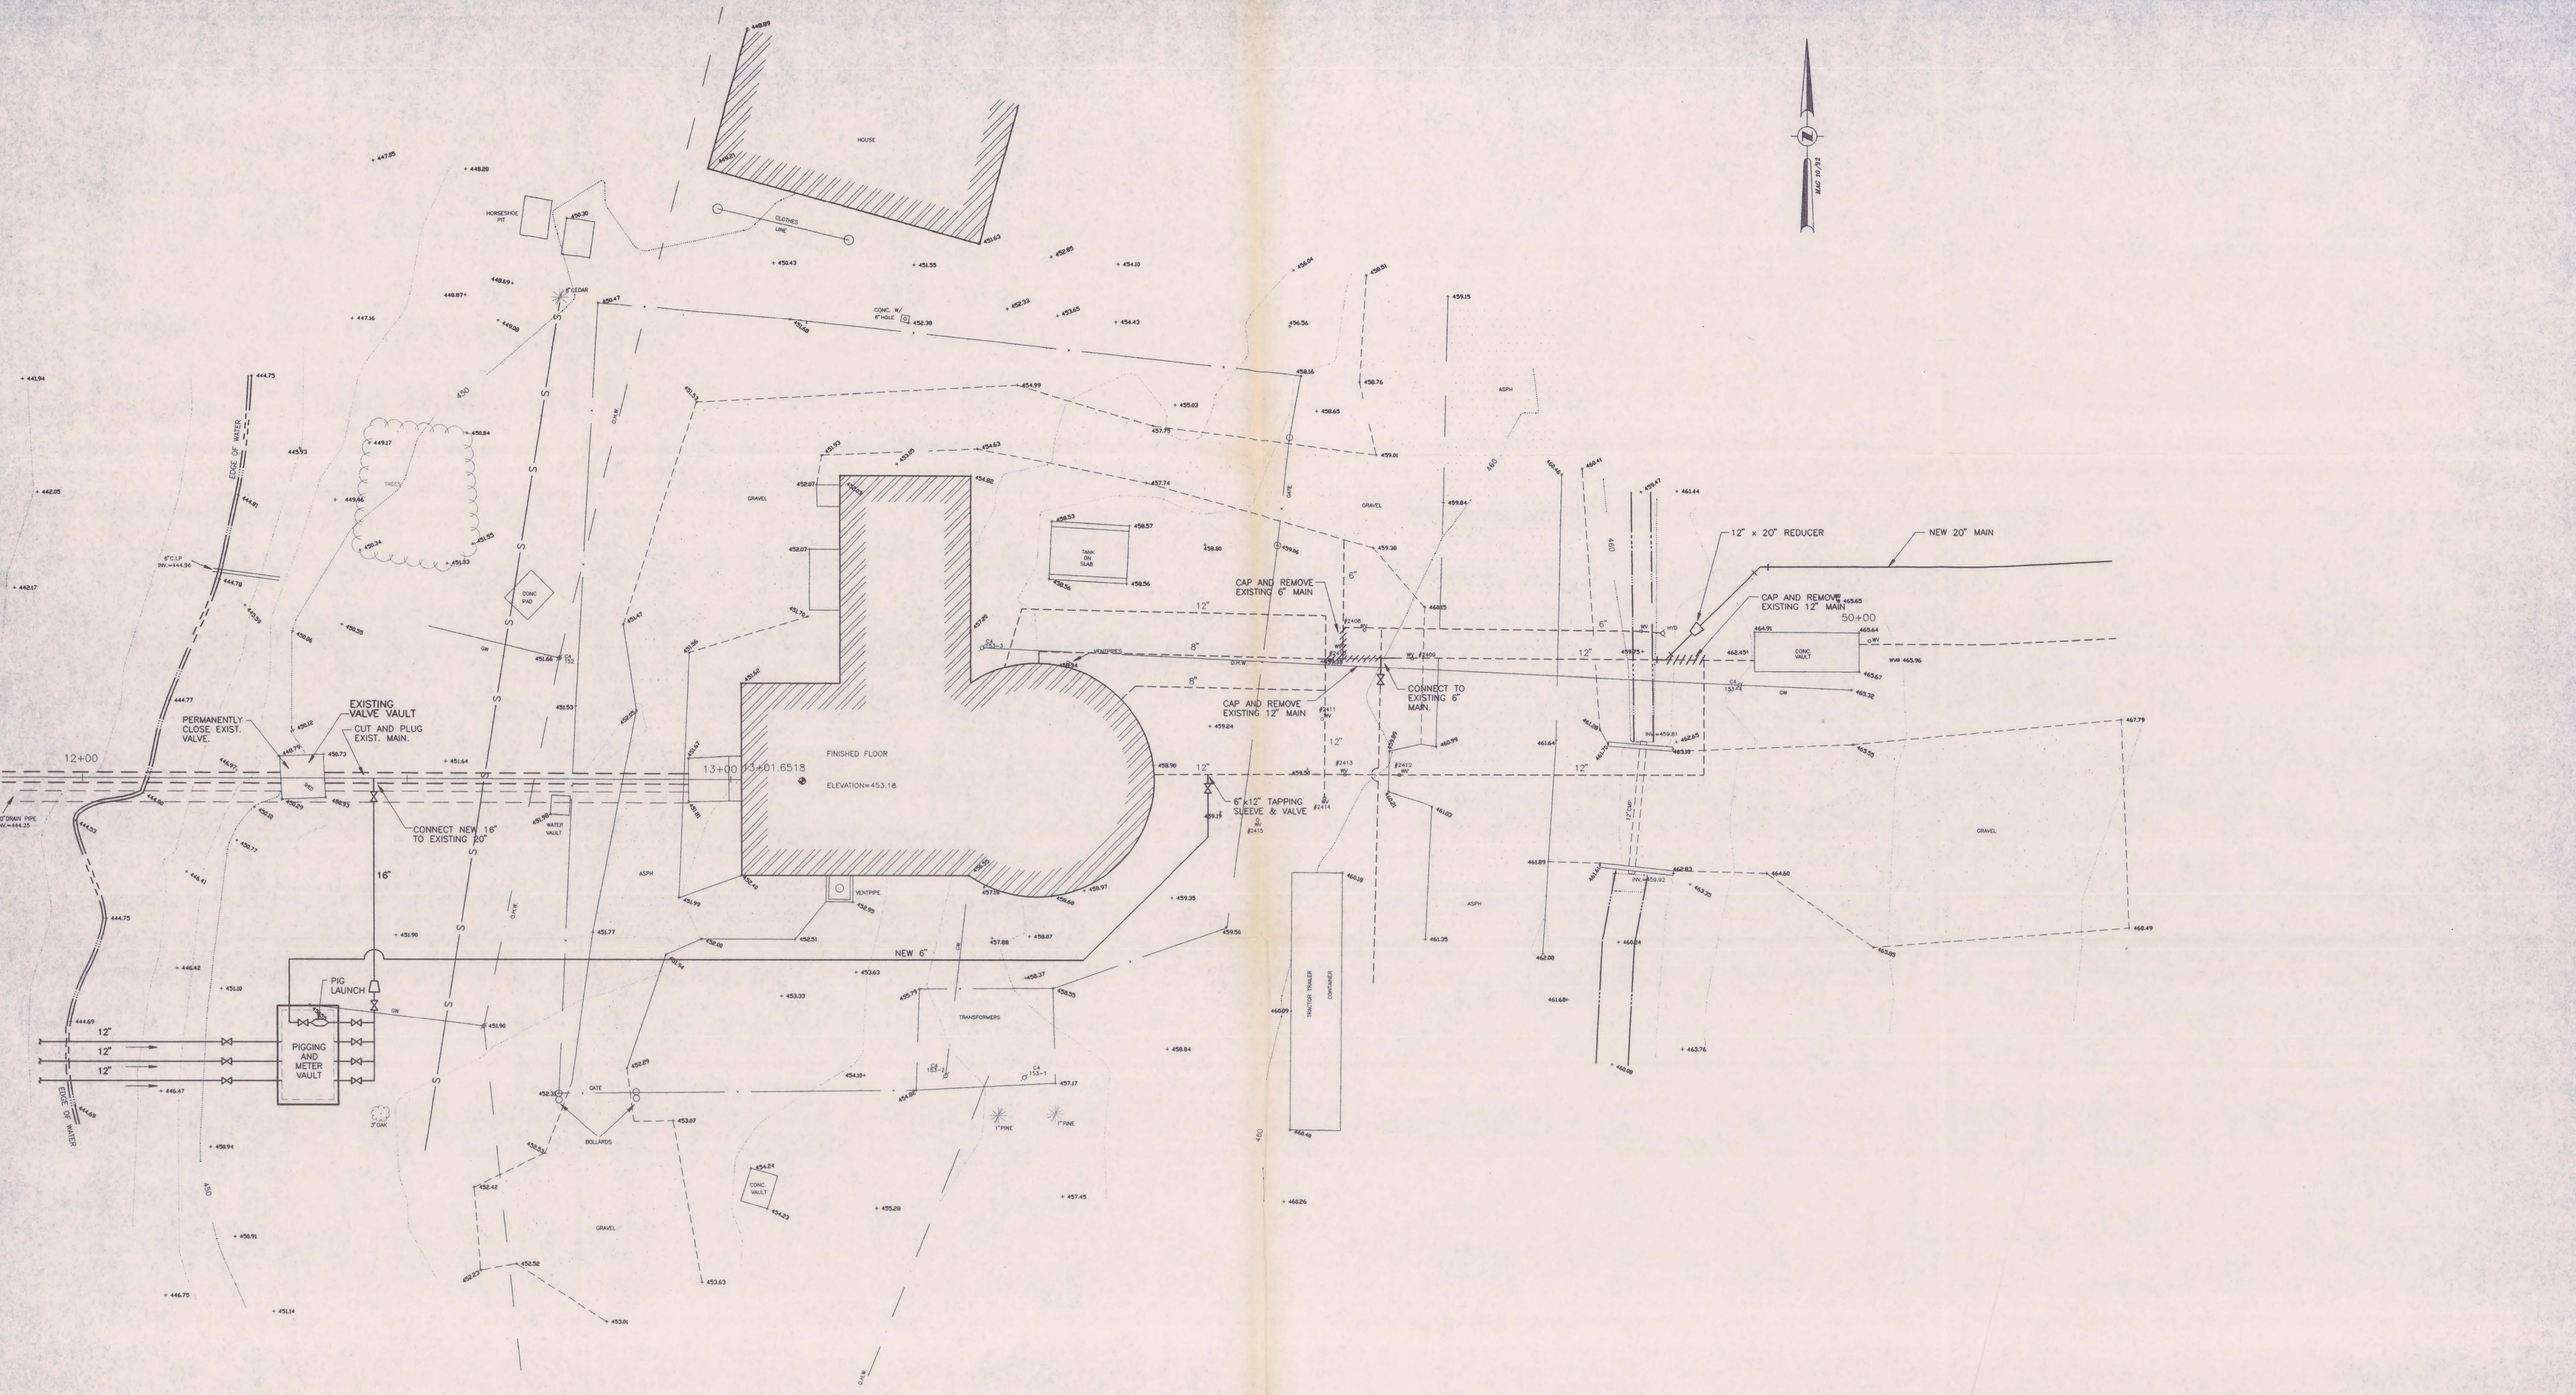

1
C2
PLAN
PUMP STATION
SCALE: 1" = 10'
CROSS REFERENCE:

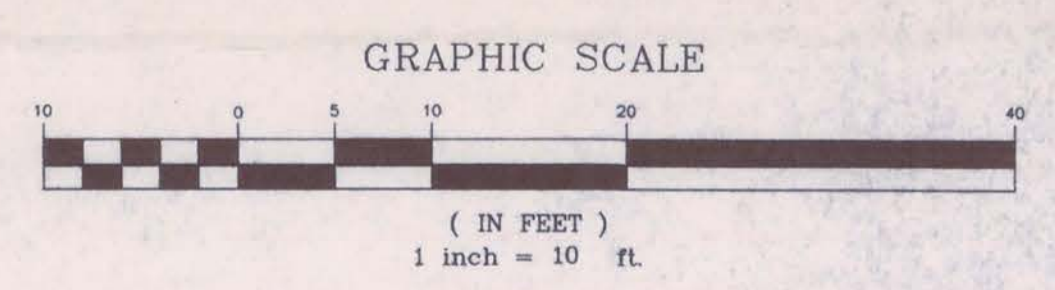

C.T. MALE ASSOCIATES, P.C.
APR 23 1993
PRINTED AND ISSUED

Revision	Description	Date	Approved

C.T. MALE ASSOCIATES, P.C. ENGINEER - ARCHITECT 50 CENTURY HILL DRIVE LATHAM, NY 12110		U.S. ARMY ENGINEER DISTRICT CORPS OF ENGINEERS NEW YORK, NEW YORK	
Designed by: EWB Drawn by: EWB Checked by: Submitted by:	SENECA ARMY DEPOT U.S. Army Corps of Engineers WATER SUPPLY INTAKE		
Reviewed by: Concluded:	APPROVAL Recommended: Approved by:	Sheet reference number: X-X	Date: 2/17/93 Scale: 1" = 10' Sheet of
FIGURE 4 PROPOSED PUMPING STATION SITE PLAN NEW YORK			

FILE NO. 104-53-41