


Apr 22, 1993 - 14:41

PLOT SCALE FACTOR: 1=1

CAD DWG. FILE NAME: PED2.DWG

CAD DWG. FILE NAME: PF02.DWG

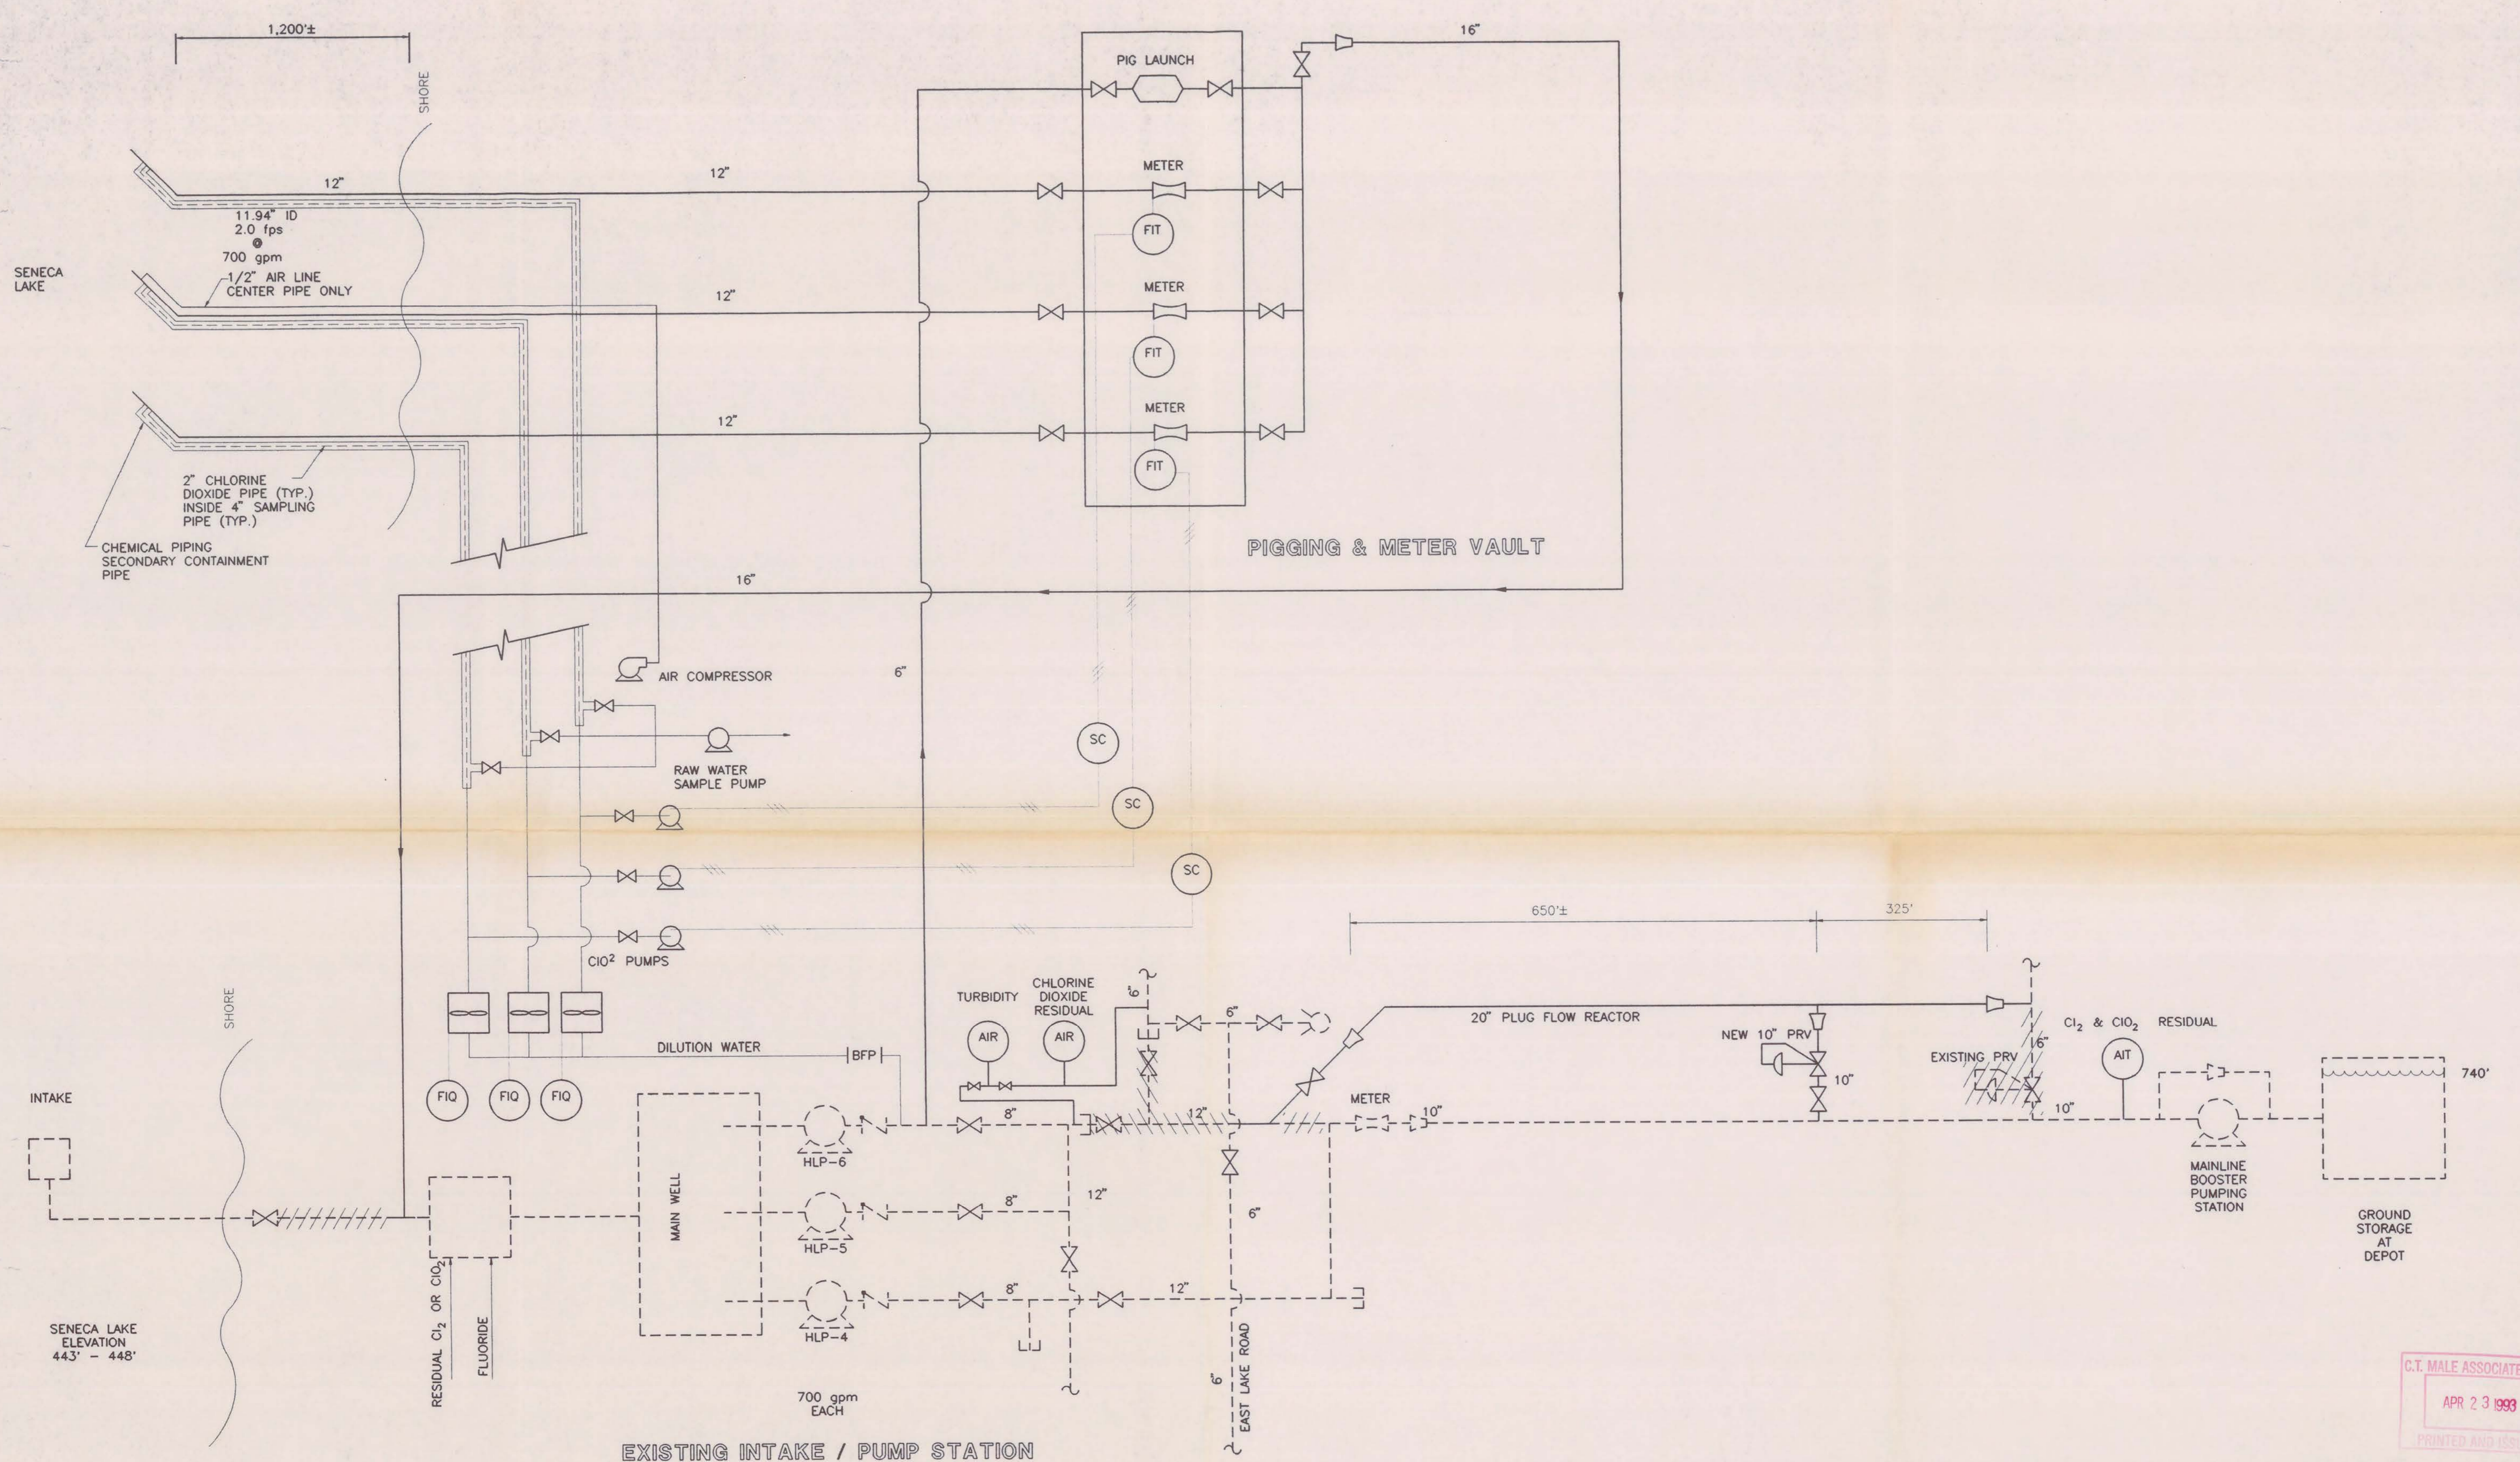

C.T. MALE ASSOCIATES, P.C.  
 APR 23 1993  
 PRINTED AND ISSUED

EXISTING INTAKE / PUMP STATION

DATE	REVISIONS RECORD/ DESCRIPTION	DRAFTED	CHECK	APPR.

UNAUTHORIZED ALTERATION OR ADDITION TO THIS DOCUMENT IS A VIOLATION OF SECTION 2 OF THE NEW YORK STATE EDUCATION LAW.  
 © 1992 C.T. MALE ASSOCIATES P.C.  
 PROJ. NO: 92.0894  
 DESIGNED:  
 DRAFTED: E.W.B.  
 CHECKED:

**SENECA ARMY DEPOT  
 WATER SUPPLY INTAKE**

**FIGURE 6  
 PROPOSED PROCESS FLOW DIAGRAM**

**C.T. MALE ASSOCIATES, P.C.**  
 50 CENTURY HILL DRIVE, P.O. BOX 727, LATHAM, NY 12110  
 (518) 786-7400 • FAX (518) 786-7299  
 ENGINEERING • SURVEYING • ARCHITECTURE • LAND PLANNING  
 LANDSCAPE ARCHITECTURE • COMPUTER SERVICES

SCALE: NONE  
 SHEET OF  
 DATE: 2/17/93  
 DWG. NO: 92-638

104-53-114